



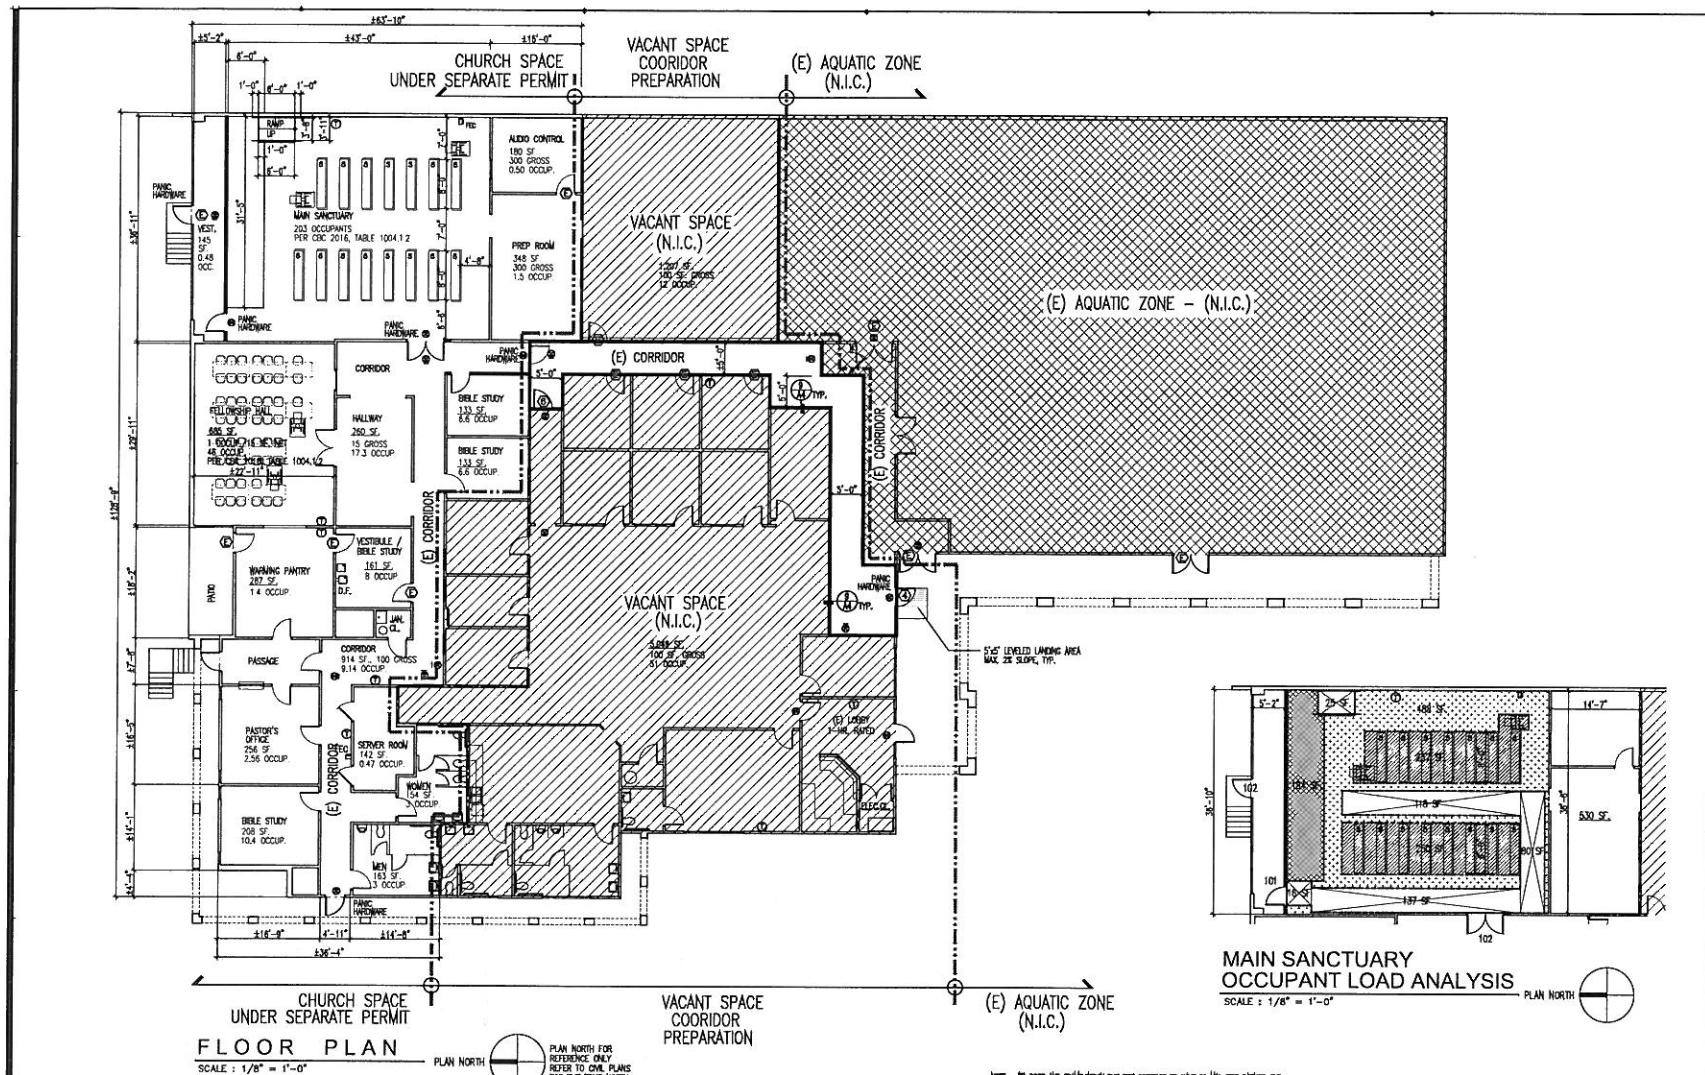

DOOR SCHEDULE									
LOCATION	TYPE	DOOR TYPE	FRAME	HINGES	LATCH-CATCHES	ACC.	FIN.	REMARK	
(4) (B)	3'-0" x 7'-0"	GLASS DOOR	ALUMINUM	1 1/2" (3)	1 1/2" (3)	GLASS DOOR	ALUMINUM	RELOCATE (3) DOOR	
(5) (A)	3'-0" x 7'-0"	GLASS DOOR	ALUMINUM	1 1/2" (3)	1 1/2" (3)	GLASS DOOR	ALUMINUM	RELOCATE (3) DOOR	
(E) (B)	3'-0" x 7'-0"	GLASS DOOR	ALUMINUM	1 1/2" (3)	1 1/2" (3)	GLASS DOOR	ALUMINUM	RELOCATE (3) DOOR	

EXISTING TO REMAIN & RELOCATION

REPLACE WITH LEVER TYPE HARDWARE OR PIANO HARDWARE AS NOTED, TYP.

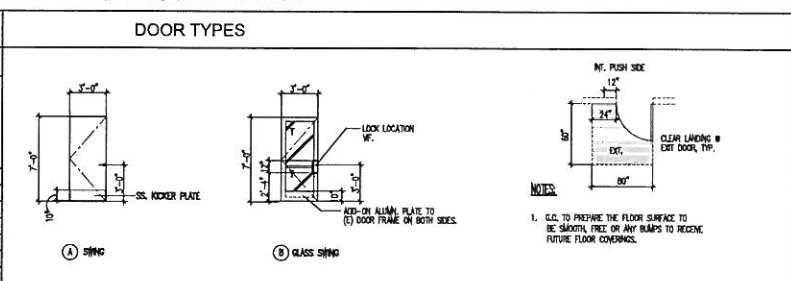

Revisions / Revisions		
No.	Date	Description
7-07-2017	07-07-2017	07-07-2017
8-07-2017	07-07-2017	07-07-2017
10-07-2017	07-07-2017	07-07-2017
1-4-2018	07-07-2017	07-07-2017

Project Name:
TENANT IMPROVEMENT &
PROPOSED USE FOR

JESUS BAPTIST USA CONFERENCE

1138 E. SIXTH ST., #C
CORONA, CA 92879

Consultants

LEGEND

- EXISTING WALLS TO BE REMOVED
- EXISTING DOORS AND PLUMBING FIXTURES TO BE REMOVED
- NEW INTERIOR PARTITION
- 5/8" CP, 30. AS SPECIFIED
- 2x4 WOOD STUDS @ 16" O.C.
- BLOCKING @ 4" O.C. VERTICAL & UP TO 3" ABOVE JOIST IT, AS STACKEED BLOCKING @ 4" O.C.
- EXISTING WALLS TO REMAIN
- EXISTING WINDOWS TO REMAIN

OCCUPANT LOAD ANALYSIS FOR EXITING

- STANDING SPACE - 3 NET
 - SEAT, 48 SQ. / 5 NET = 96 OCCUP.
 - PER CBC 2014, SEC. 1004.4
 - 81 OCCUPANTS AT FIXED SEATS
 - STAGE / PLATFORM AREA - 15 NET
 - 184 / 15 = 12 OCCUP.
 - ACCESS AREA 378 SQ. - NO OCCUP.
 - PREP. / STORAGE - 300 SQ. GROSS
 - 630 SQ. / 300 SQ. = 1.87 OCCUP.
- DOCUMENT LOAD TOTAL: 203 OCCUPANTS**
TWO EXITS ARE 157'

Seal



Architect
AREAN
architects, inc.
14300
Village Square Dr.
Riverside, CA 92503
Tel: 951-509-1900
Fax: 951-509-1900
www.areanarchitects.com

Drawing Description

FLOOR PLAN

Project No.
2016-1104

Sheet No.

A2