 


DESIGN
REVIEW

ELECTRICAL SITE PLAN

AWING
MBER:

ES101




XX.XX.XXXX



A16050

DPR16-027

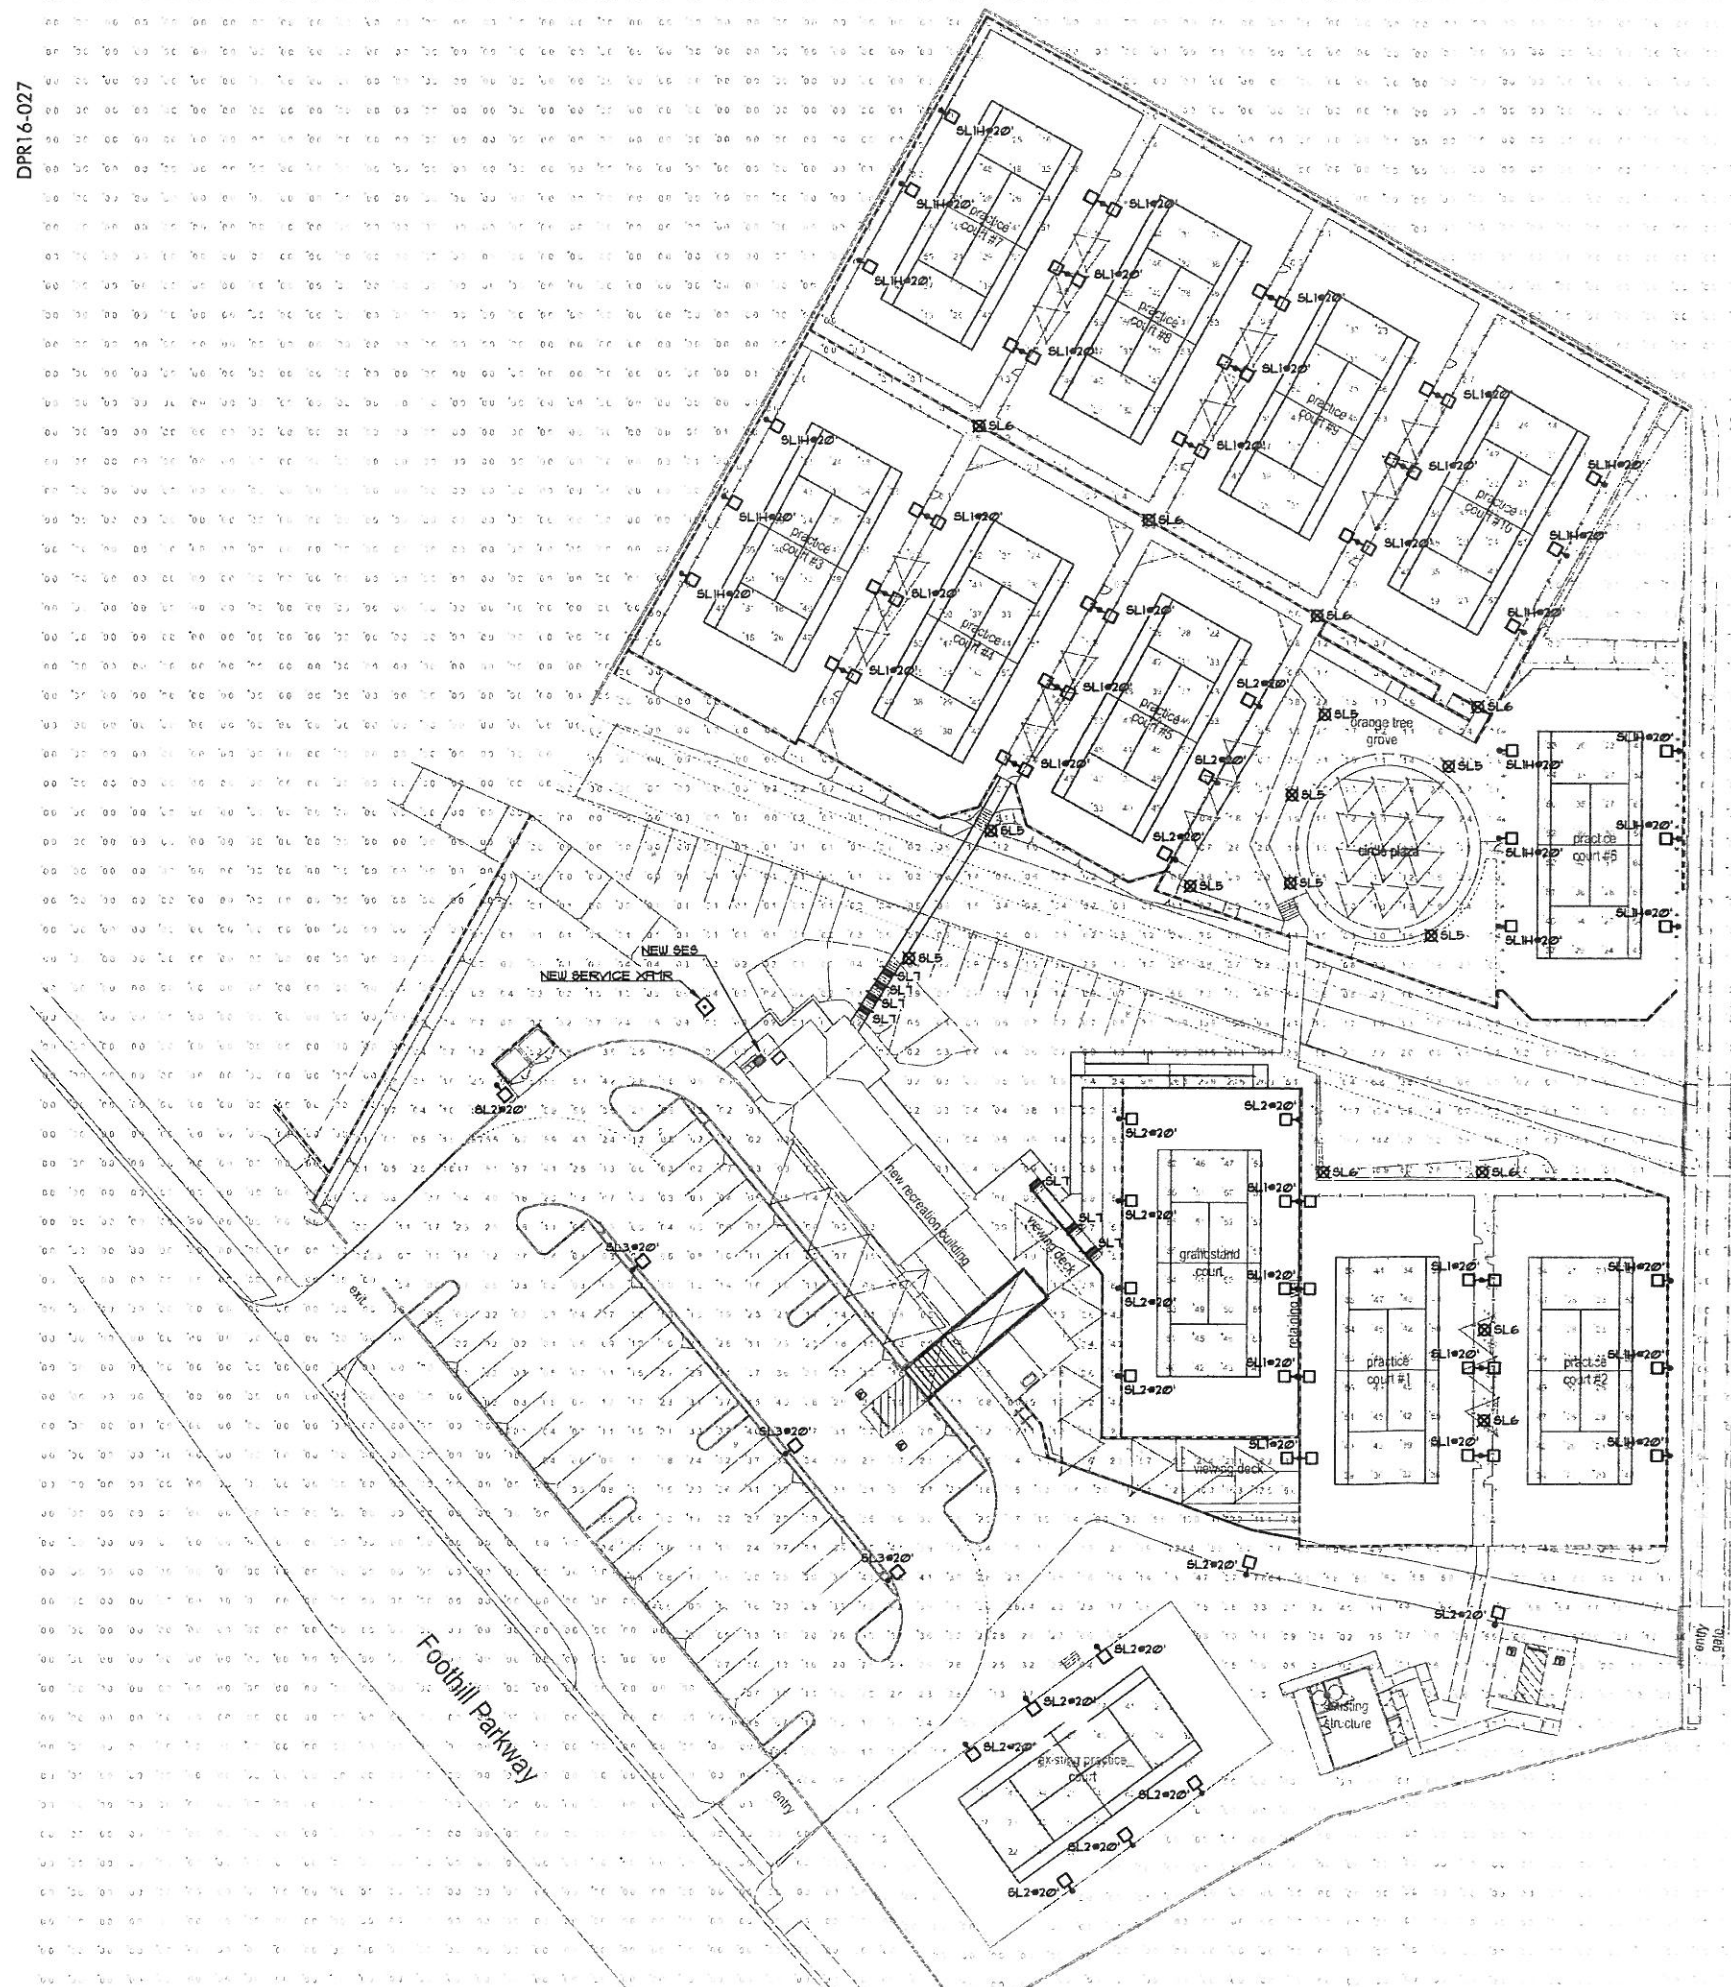

ELECTRICAL SITE PHOTOMETRIC STUDY



**PROGRESS DRAWING
NOT FOR CONSTRUCTION**

PROGRESS DRAWING SUBJECT TO CHANGE.
DRAWING INCOMPLETE AND NOT INTENDED
FOR PERMITTING, PRICING, OR CONSTRUCTION

TUES INCORPORATED
DESIGN • CONSTRUCTION • INTERIORS

TMSEA **ENGINEERING
CONSULTANTS**

7878 North 16th St., Suite 140
Phoenix, AZ 85020
T: (602) 943-8424
mse-phx.com



PHX
ARCHITECTURE
LIVING • ARCHITECTURE

15990 N. GREENWAY-HAYDEN
LOOP
SUITE C-100
SCOTTSDALE, AZ 85260
T 480.477.1111
F 480.386.3858
PHXARCH.COM

All reports, drawings, specifications, computer files, field notes, notes, other documents and instruments created by or for the Architect are the sole property of the Architect. The design and development of services shall remain the property of the Architect. Pension Architecture, LLC dba PAA Architecture. The Architect shall retain all common law, statutory and other reserved rights, including copyright therein. The use of this creation shall be restricted to the original site for which it was prepared and publication thereof is expressly limited to such use. Reuse, reproduction or publication by any method is prohibited without written consent from Pension Architecture, LLC dba PAA Architecture. Copyright © 2017

A+F TENNIS CENTER
1695 E. CHASE DRIVE
CORONA, CA 92881

DESIGN
REVIEW

DRAWN BY: MSA
CHECKED BY: MSA
REVISIONS:
△
△
△
PROJECT NO: 16058
DATE: MAY 5, 2017
CONTENTS:

ELECTRICAL SITE
PHOTOMETRIC STUDY

SCALE: NTS

ES102

XX XX XXXX